


NOTES

- LEGEND ON SHT. 12
- PLAN IS DIAGNOSTIC - ALL TRENCHING SHALL BE DONE IN PLANTING AREAS WHEN POSSIBLE
- LOCATION OF CONTROLLER "B" ON SHT. NO. 7

CONSTRUCTION NOTES:

- 1) 2" RIGID SERVICE BOX
- 2) PLACE 1 1/2" C WITH 3" x 4" THW
- 3) PLACE 1 1/2" C - 2" x 12 THW & 1" x 12 THW GROUND
- 4) PLACE 2" CONDUIT STUD
- 5) PLACE NEW SERVICE CAPI TLEGO CAT. # 21-100 LEO OR APPROVED EQUAL

HAVENSIDE PARK SITE

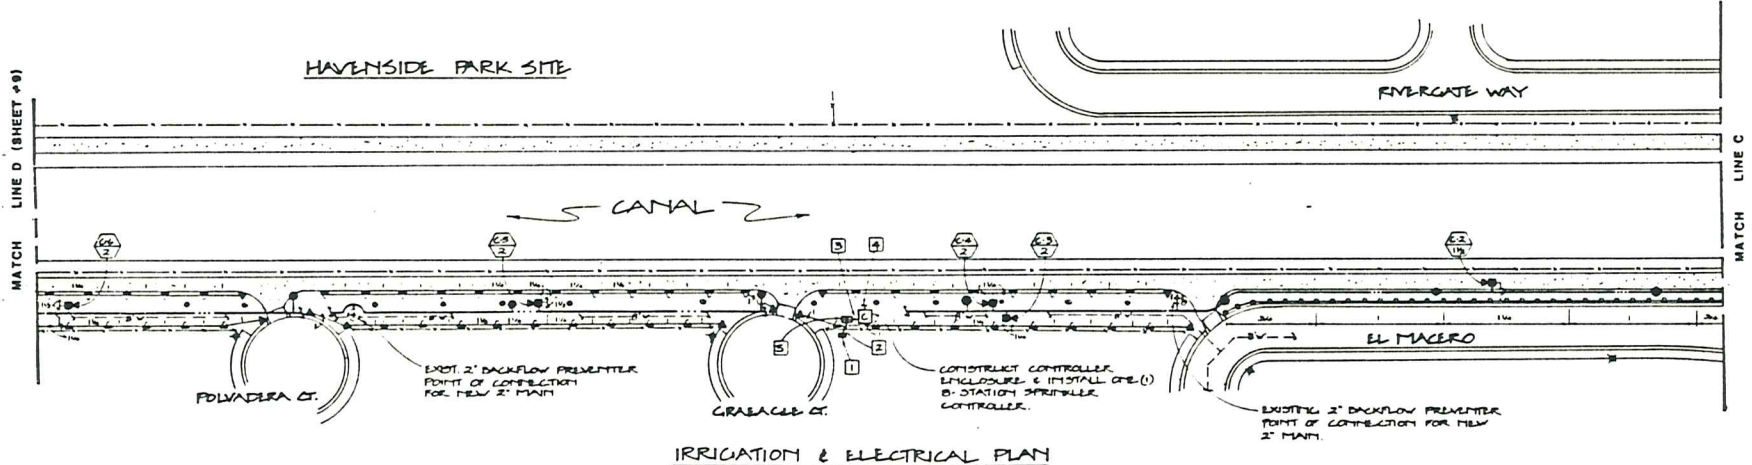

NO	DESCRIPTION	DATE	BY
1	SPRINKLERS CHANGED	4-27-07	


DRAWN BY:
 DESIGNED BY:
 LANDSCAPE ARCHITECT:
 DATE: 2-11-07
 FIELD BOOK: SCALE: 1" = 40'

CITY OF SACRAMENTO
 DEPARTMENT OF PARKS & COMMUNITY SERVICES



POCKET CANAL PARKWAY
 IRRIGATION & ELECTRICAL PLAN

SHEET **8**
 19 SHEETS
 % HAZG

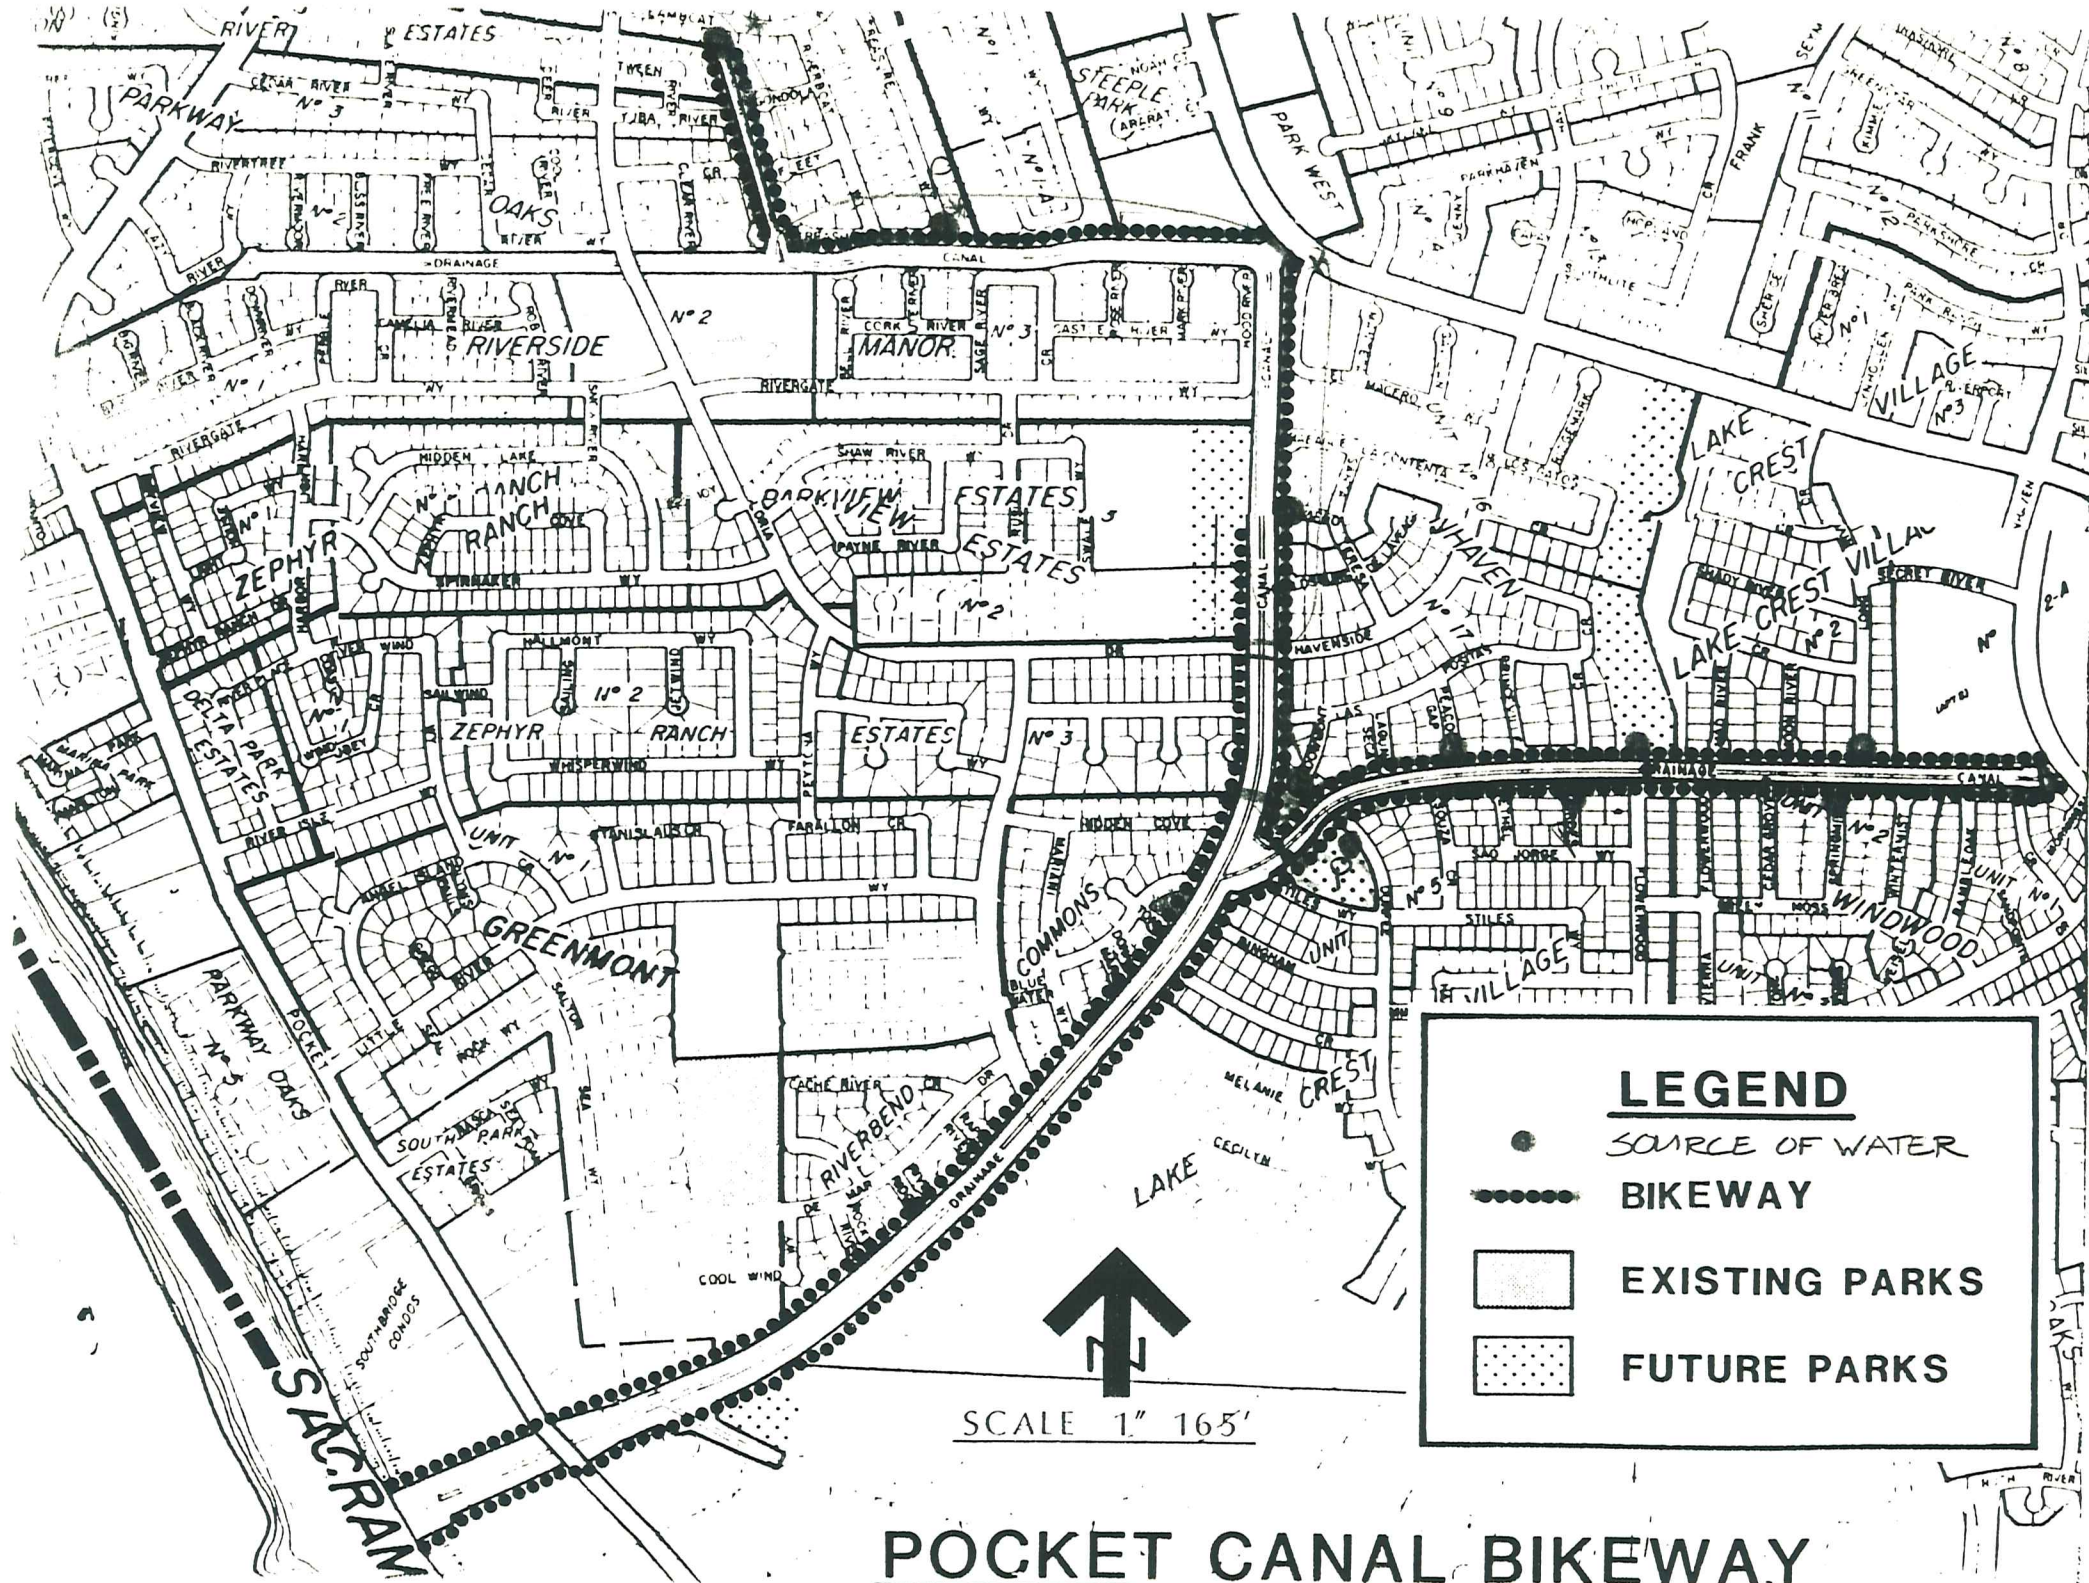

POCKET CANAL BIKEWAY